


**1 MAIN ELECTRICAL PLAN**  
 scale: 3/16" = 1'-0"

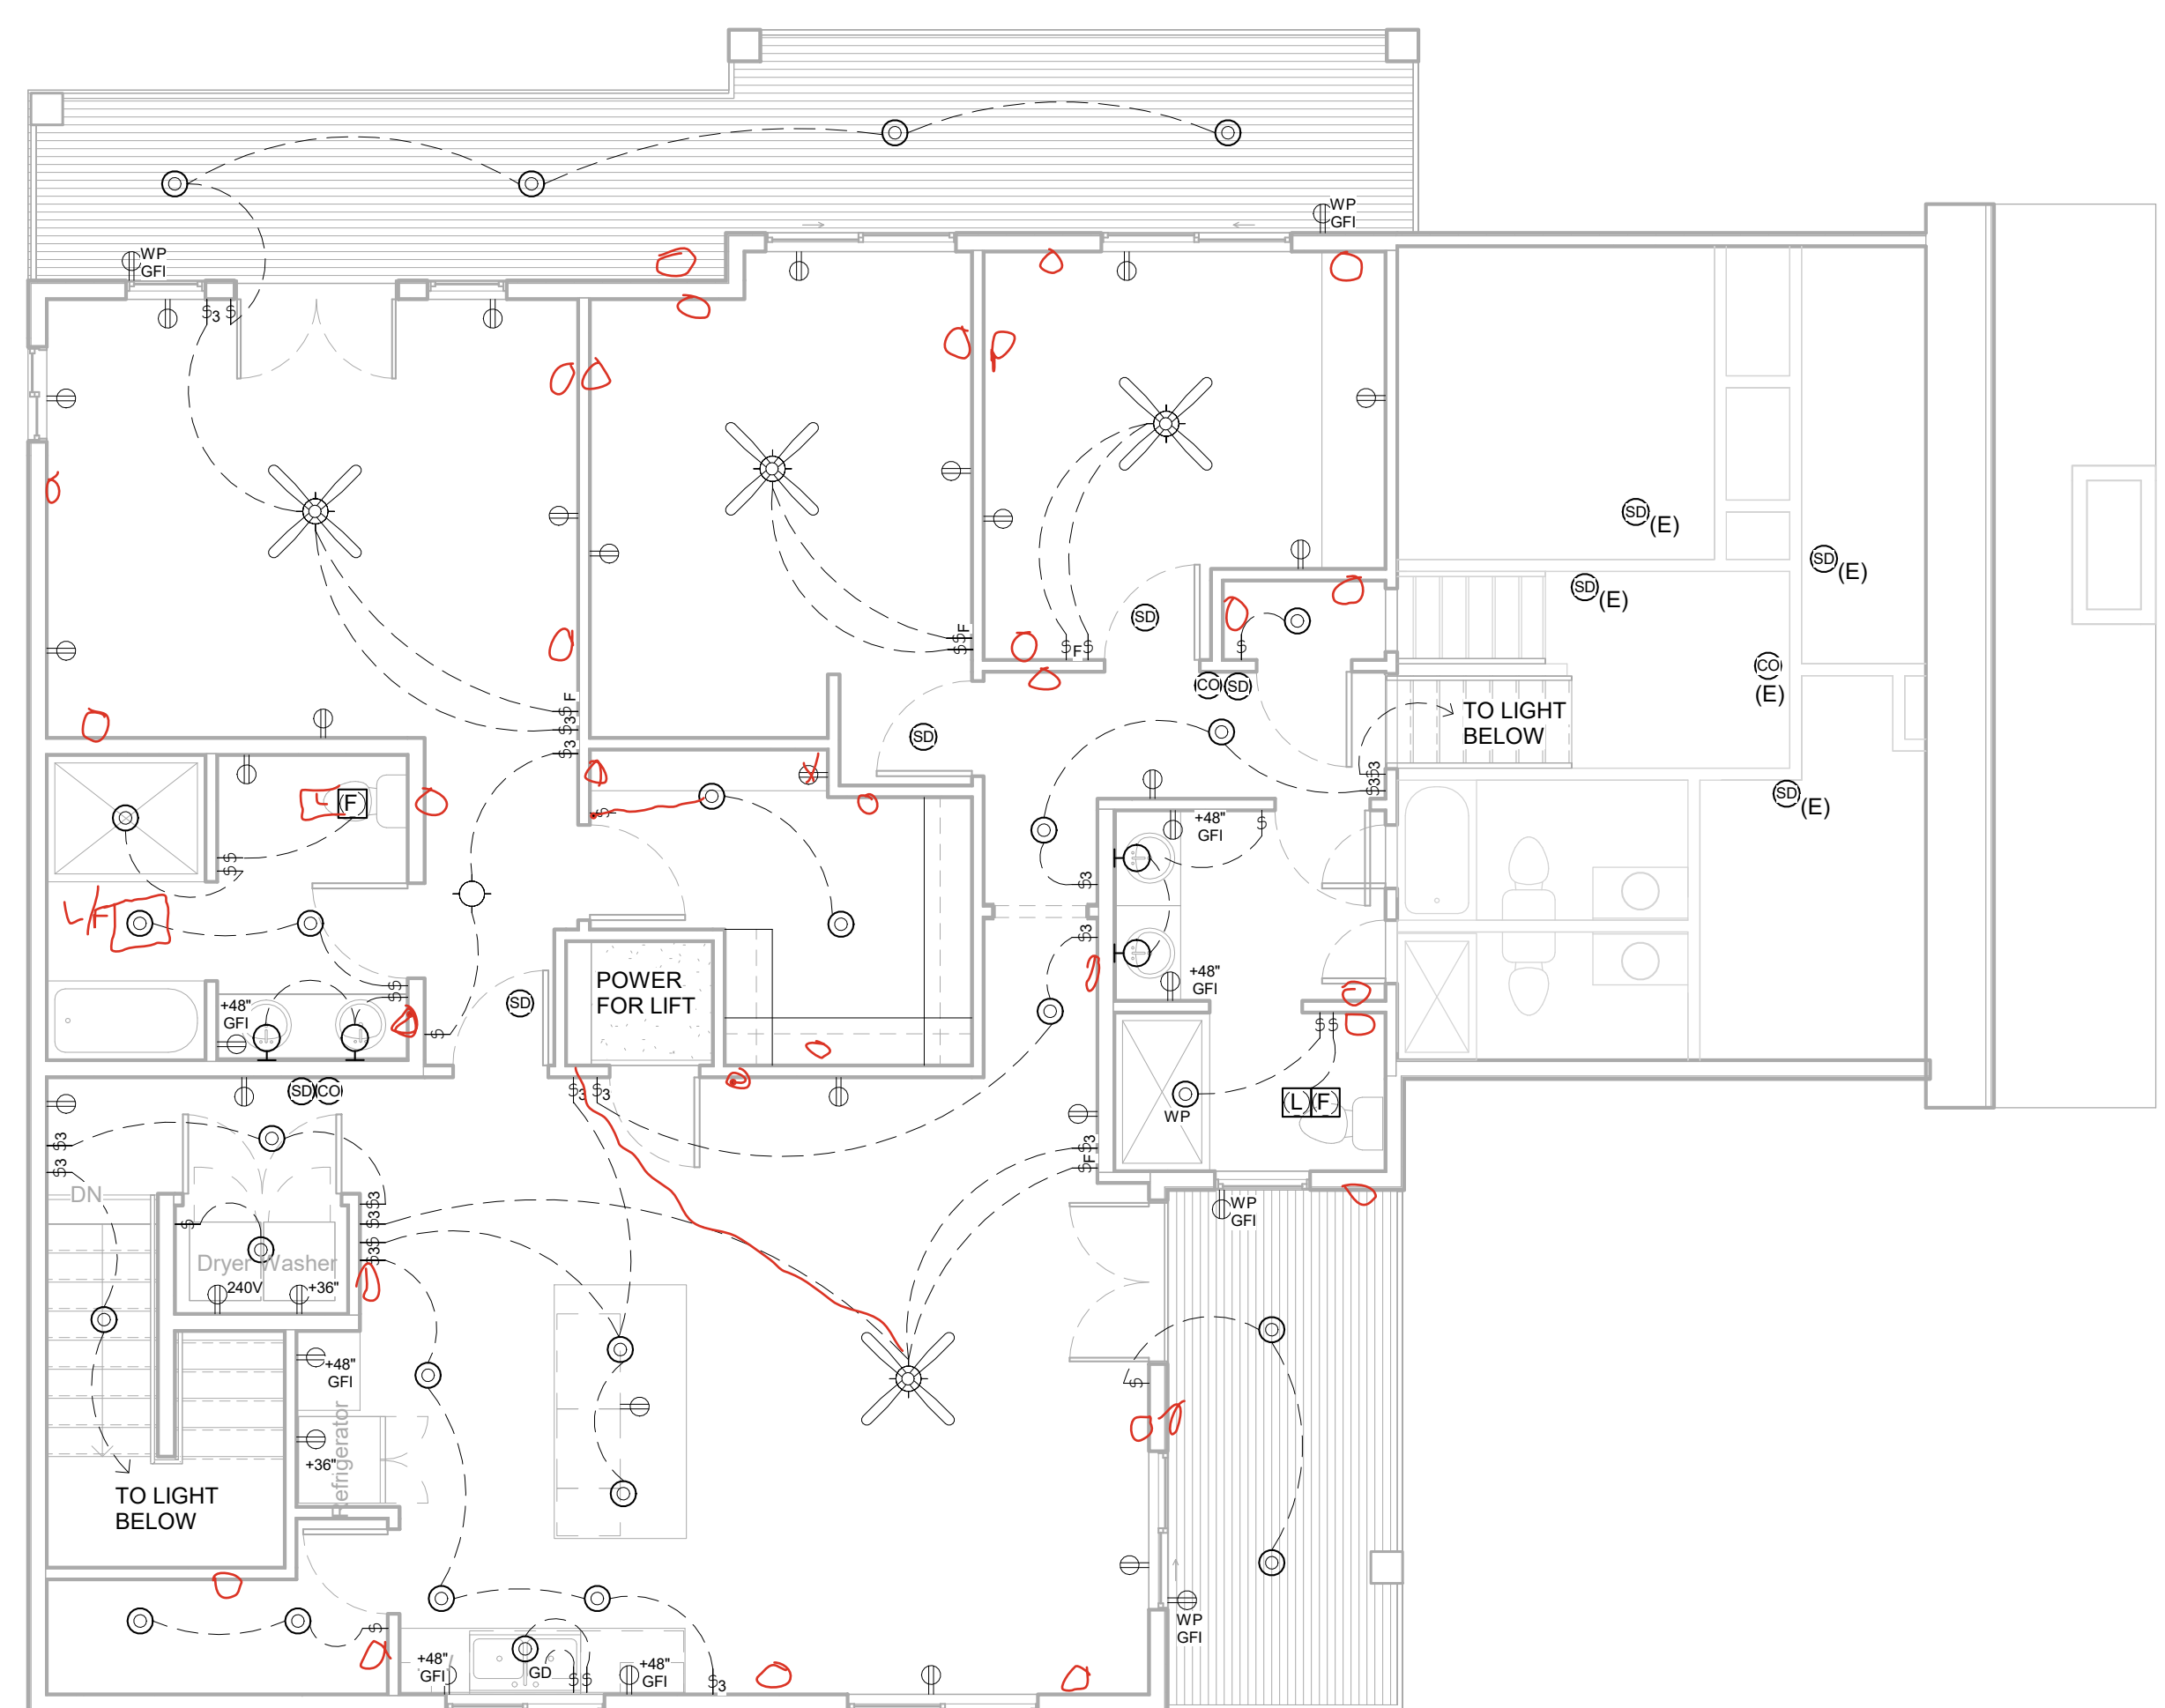

**2 UPPER ELECTRICAL PLAN**  
 scale: 3/16" = 1'-0"

NOTE: SMOKE AND CO2 DETECTORS SHALL BE HARD-WIRED AND INTERCONNECTED.

**ELECTRICAL-MECHANICAL LEGEND**

⊥	SINGLE POLE
⊥ <sub>3</sub>	THREE-WAY
⊕	DUPLEX OUTLET
GFI ⊕	GFI OUTLET
WP ⊕	WATERPROOF OUTLET
GDO ⊕	GARAGE DOOR OPENER
DW ⊕	DISHWASHER
GD	GARBAGE DISPOSAL
▲	DATA/ETHERNET
⊙	SMOKE DETECTOR
⊙	CO2 DETECTOR
⊙	SURFACE PUCK LIGHTS
⊕	DIRECTED SURFACE OR PENDANT
○	SURFACE MOUNT (CEILING)
○	WALL MOUNT
—	UNDERCABINET LIGHTING
TV	TV HOOK UP
□	SURFACE OR PENDANT FLUORESCENT
FL	LIGHT/FAN
■	HVAC
⊗	CEILING FAN
PC	PHOTO CELL

NOTE: MECHANICAL-ELECTRICAL DESIGN IS SCHEMATIC. FINAL LOCATIONS TO BE DETERMINED BY OWNER AND LICENSED PROFESSIONALS.

BENINTENDI ARCHITECTURAL DESIGNS © 2024

**BENINTENDI  
 DESIGNS**

1508 S BIGGS STREET • BOISE, IDAHO 83709  
 (208) 865-4971 • juliebenintendi@yahoo.com

**BOWLES REMODEL/ADDITION**

3705 E BOISE AVE, BOISE, IDAHO  
 DOUG & RAINI BOWLES  
 208-859-2923

REVISIONS:

1 -	8/14/24 CITY COMMENTS
2 -	10/20/24 PLAN MOD

Date:	5/22/24
Scale:	As indicated
Drawn By:	JAB
Checked By:	-
Job:	23002

Sheet  
**A801**

**ELECTRICAL-MECHANICAL PLANS**

PERMIT SET